



**ADDENDUM NO. 5**

**September 6, 2023**

**RE: Grant County Extension Office  
105 Banton Rouge Road  
Williamstown, Kentucky 41097  
Project No. 20026**

**FROM: Brandstetter Carroll Inc.  
2360 Chauvin Drive  
Lexington, Kentucky 40517  
Phone 859-268-1933  
Fax 859-268-3341**

**TO: Plan Holders**

---

This Addendum forms a part of the Re-Bid Documents dated May 26, 2023. Each Bidder shall acknowledge receipt of this Addendum in the space provided on the Bid Form. Failure to do so may subject the Bidder to disqualification.

This Addendum consists of one (1) page and the following attachments:

- Full Size Sheet E-001 Electrical Site Plan

**CHANGES TO SPECIFICATIONS:**

1. 042000 – Unit Masonry
  - a. Brick installation shall be in a continuous running bond.

**CHANGES TO DRAWINGS:**


1. E-001 – Electrical Site Plan
  - a. Refer to full size sheet E-001 Electrical Site Plan.

**END OF ADDENDUM NO. 5**

PLAN NOTES	
①	EXISTING 150 KVA UTILITY TRANSFORMER TO BE REPLACED WITH NEW.
②	NEW ELECTRICAL SERVICE CONDUITS AND WIRE. REFER TO SINGLE LINE RISER DIAGRAM ON E-601 FOR MORE INFORMATION. PROVIDE (1) SPARE 4" PVC CONDUIT FROM TRANSFORMER TO CT CABINET.
③	REPLACE EXISTING CONDUIT AND WIRE WITH NEW. REFER TO SINGLE LINE DIAGRAM FOR WIRE AND CONDUIT SIZE.
④	PROVIDE NEW CONCRETE PAD PER LOCAL UTILITY COMPANY STANDARDS.
⑤	PROVIDE POWER TO NEW LIFT STATION. COORDINATE EXACT LOCATION, OVERCURRENT PROTECTION, AND FINAL CONNECTION WITH PLUMBING CONTRACTOR.
⑥	DEMO CIRCUIT SERVING EXISTING LIFT STATION BACK TO PANEL.




Lexington • Cincinnati • Cleveland • Dallas

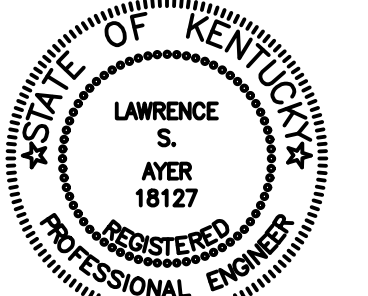


EXPIRATION DATE: 6/30/2023  
*Lawrence S. Ayer*



E2M CONSULTING ENGINEERING  
682 TUNKEDD PLACE  
CINCINNATI, OH 45206  
TEL: 513.587.0050  
www.e2m-eng.com

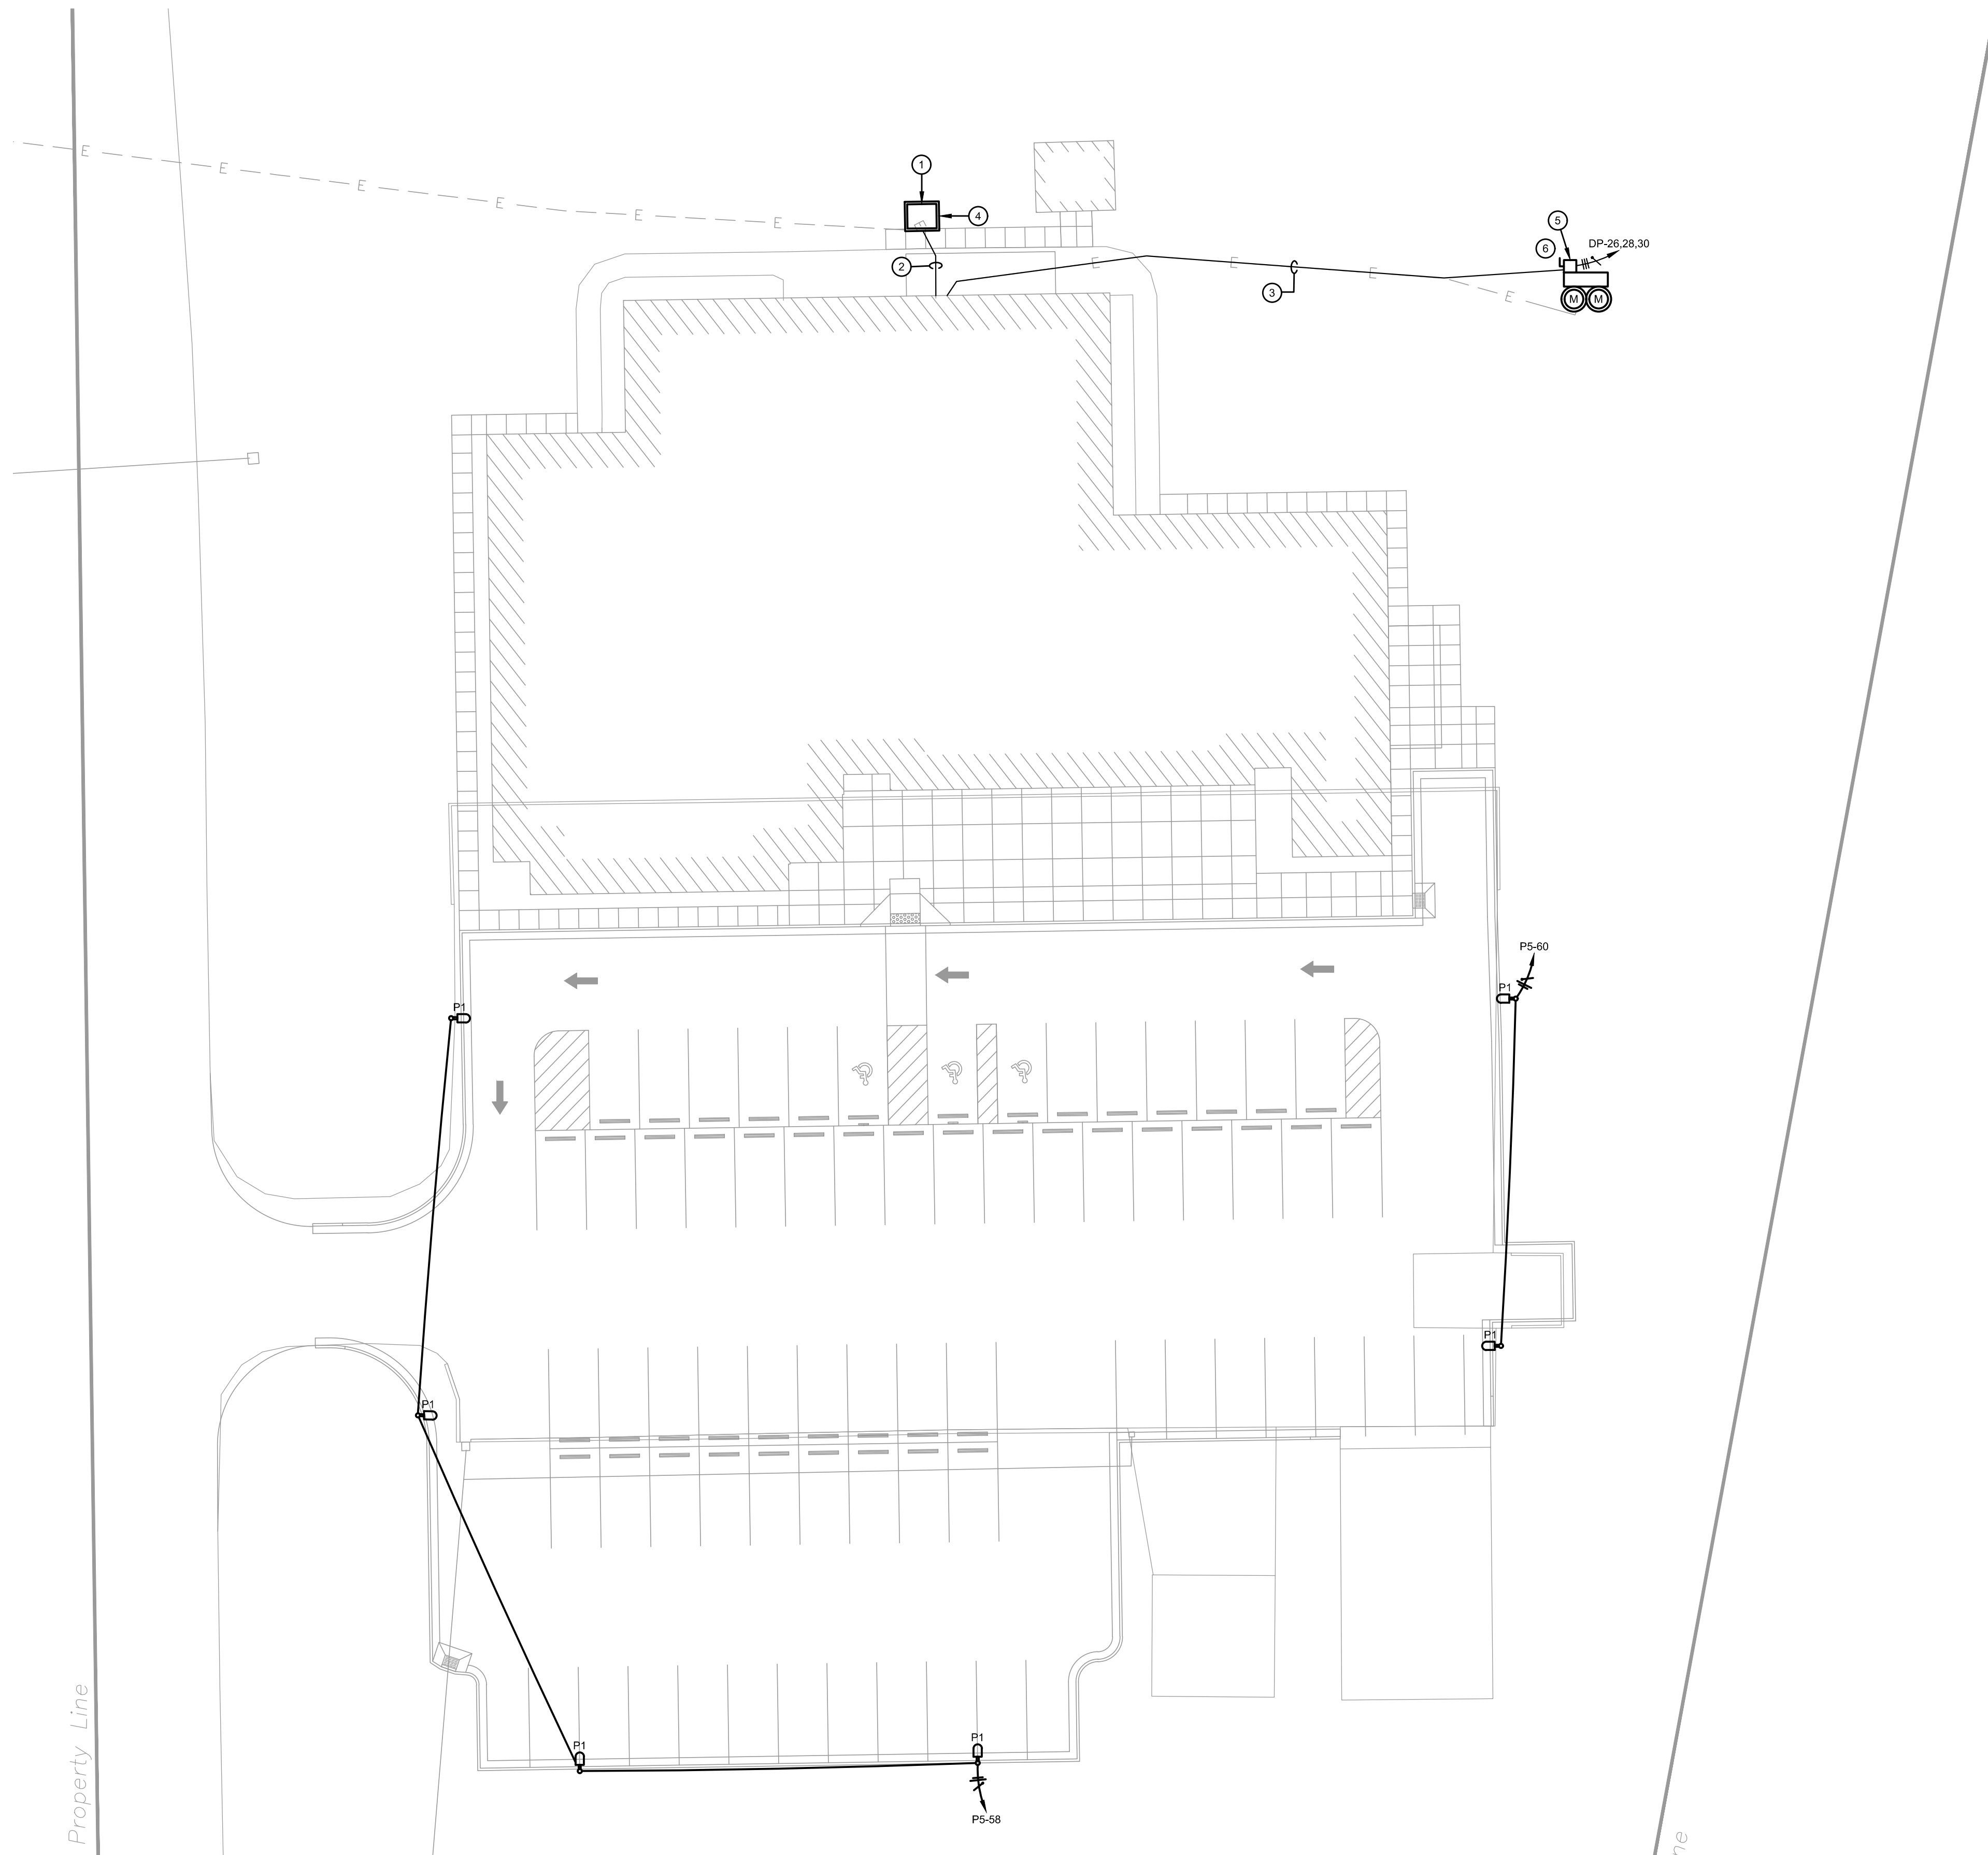

1 ELECTRICAL SITE PLAN  
E-001 SCALE: 1" = 20'-0"

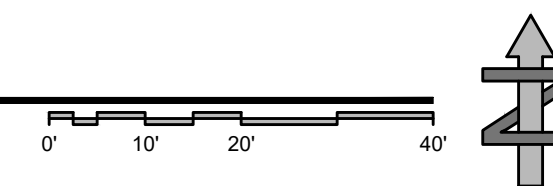

Revisions: Addendum 3, 08/31/2023  
Issue Date: May 26, 2023

**Grant County**  
Extension Office  
Renovation and Addition  
105 Baton Rouge Road  
Williamstown, Kentucky 41097

Electrical Site Plan

Project No.

20026

E-001